



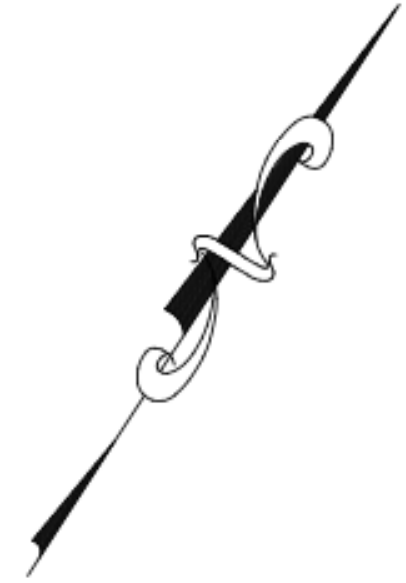

Schedule												
Symbol	Label	QTY	Manufacturer	Catalog Number	Description	Lamp	Filename	Lumens per Lamp	LLF	Wattage	Distribution	Polar Plot
	D1	4	Generation Brands	700WSPITSH-LED830	Pitch Single LED Wall Sconce; mounted at 6ft above ground	LED	102171228CHI-032 GB 700OWSPITSC-LED830.ies	803	0.9	26.2		
	D1-MS	7	Generation Brands	700WSPITSH-LED830	Pitch Single LED Wall Sconce; mounted at 6ft above ground; controlled by motion sensor by others	LED	102171228CHI-032 GB 700OWSPITSC-LED830.ies	803	0.9	26.2		
	D2	2	Generation Brands	700WSPITSH-LED830	Pitch Single LED Wall Sconce; mounted at 6ft above deck	LED	102171228CHI-032 GB 700OWSPITSC-LED830.ies	803	0.9	26.2		
	D2-MS	7	Generation Brands	700WSPITSH-LED830	Pitch Single LED Wall Sconce; mounted at 6ft above deck; controlled by motion sensor by others	LED	102171228CHI-032 GB 700OWSPITSC-LED830.ies	803	0.9	26.2		
	D3	2	Generation Brands	700WSPITSH-LED830	Pitch Single LED Wall Sconce; mounted at 6ft above deck	LED	102171228CHI-032 GB 700OWSPITSC-LED830.ies	803	0.9	26.2		
	G1	20	Generation Brands	7000WASHH93016DHUNV	Ash 16 LED Wall Sconce; mounted at 9ft	LED	103017649CHI-058 GB 7000WASHH93016DZUNVS.ies	1346	0.9	18.2		
	S1	2	Luminaire LED	TSL9 15IN 15W 30K MVOLT OP XXX	Stair Lighter TSL9; mounted at 7ft above landing	LED	TSL9_24IN_25W_FAM7_40K_OP.ies	16	0.45	15	DIRECT, SC=0=1.26, SC=90=1.34	
	S2	2	Luminaire LED	TSL9 15IN 15W 30K MVOLT OP XXX	Stair Lighter TSL9; mounted at 7ft above landing	LED	TSL9_24IN_25W_FAM7_40K_OP.ies	16	0.45	15	DIRECT, SC=0=1.26, SC=90=1.34	

Statistics

Description	Symbol	Avg	Max	Min	Max/Min	Avg/Min
Deck/Patio		2.3 fc	5.4 fc	0.7 fc	7.7:1	3.3:1
Driveway 1 (west)		1.0 fc	5.8 fc	0.0 fc	N/A	N/A
Driveway 2 (middle)		2.5 fc	19.7 fc	0.0 fc	N/A	N/A
Driveway 3 (east)		2.2 fc	19.0 fc	0.0 fc	N/A	N/A
Ground		0.1 fc	5.2 fc	0.0 fc	N/A	N/A
Landing		2.5 fc	3.3 fc	1.6 fc	2.1:1	1.6:1

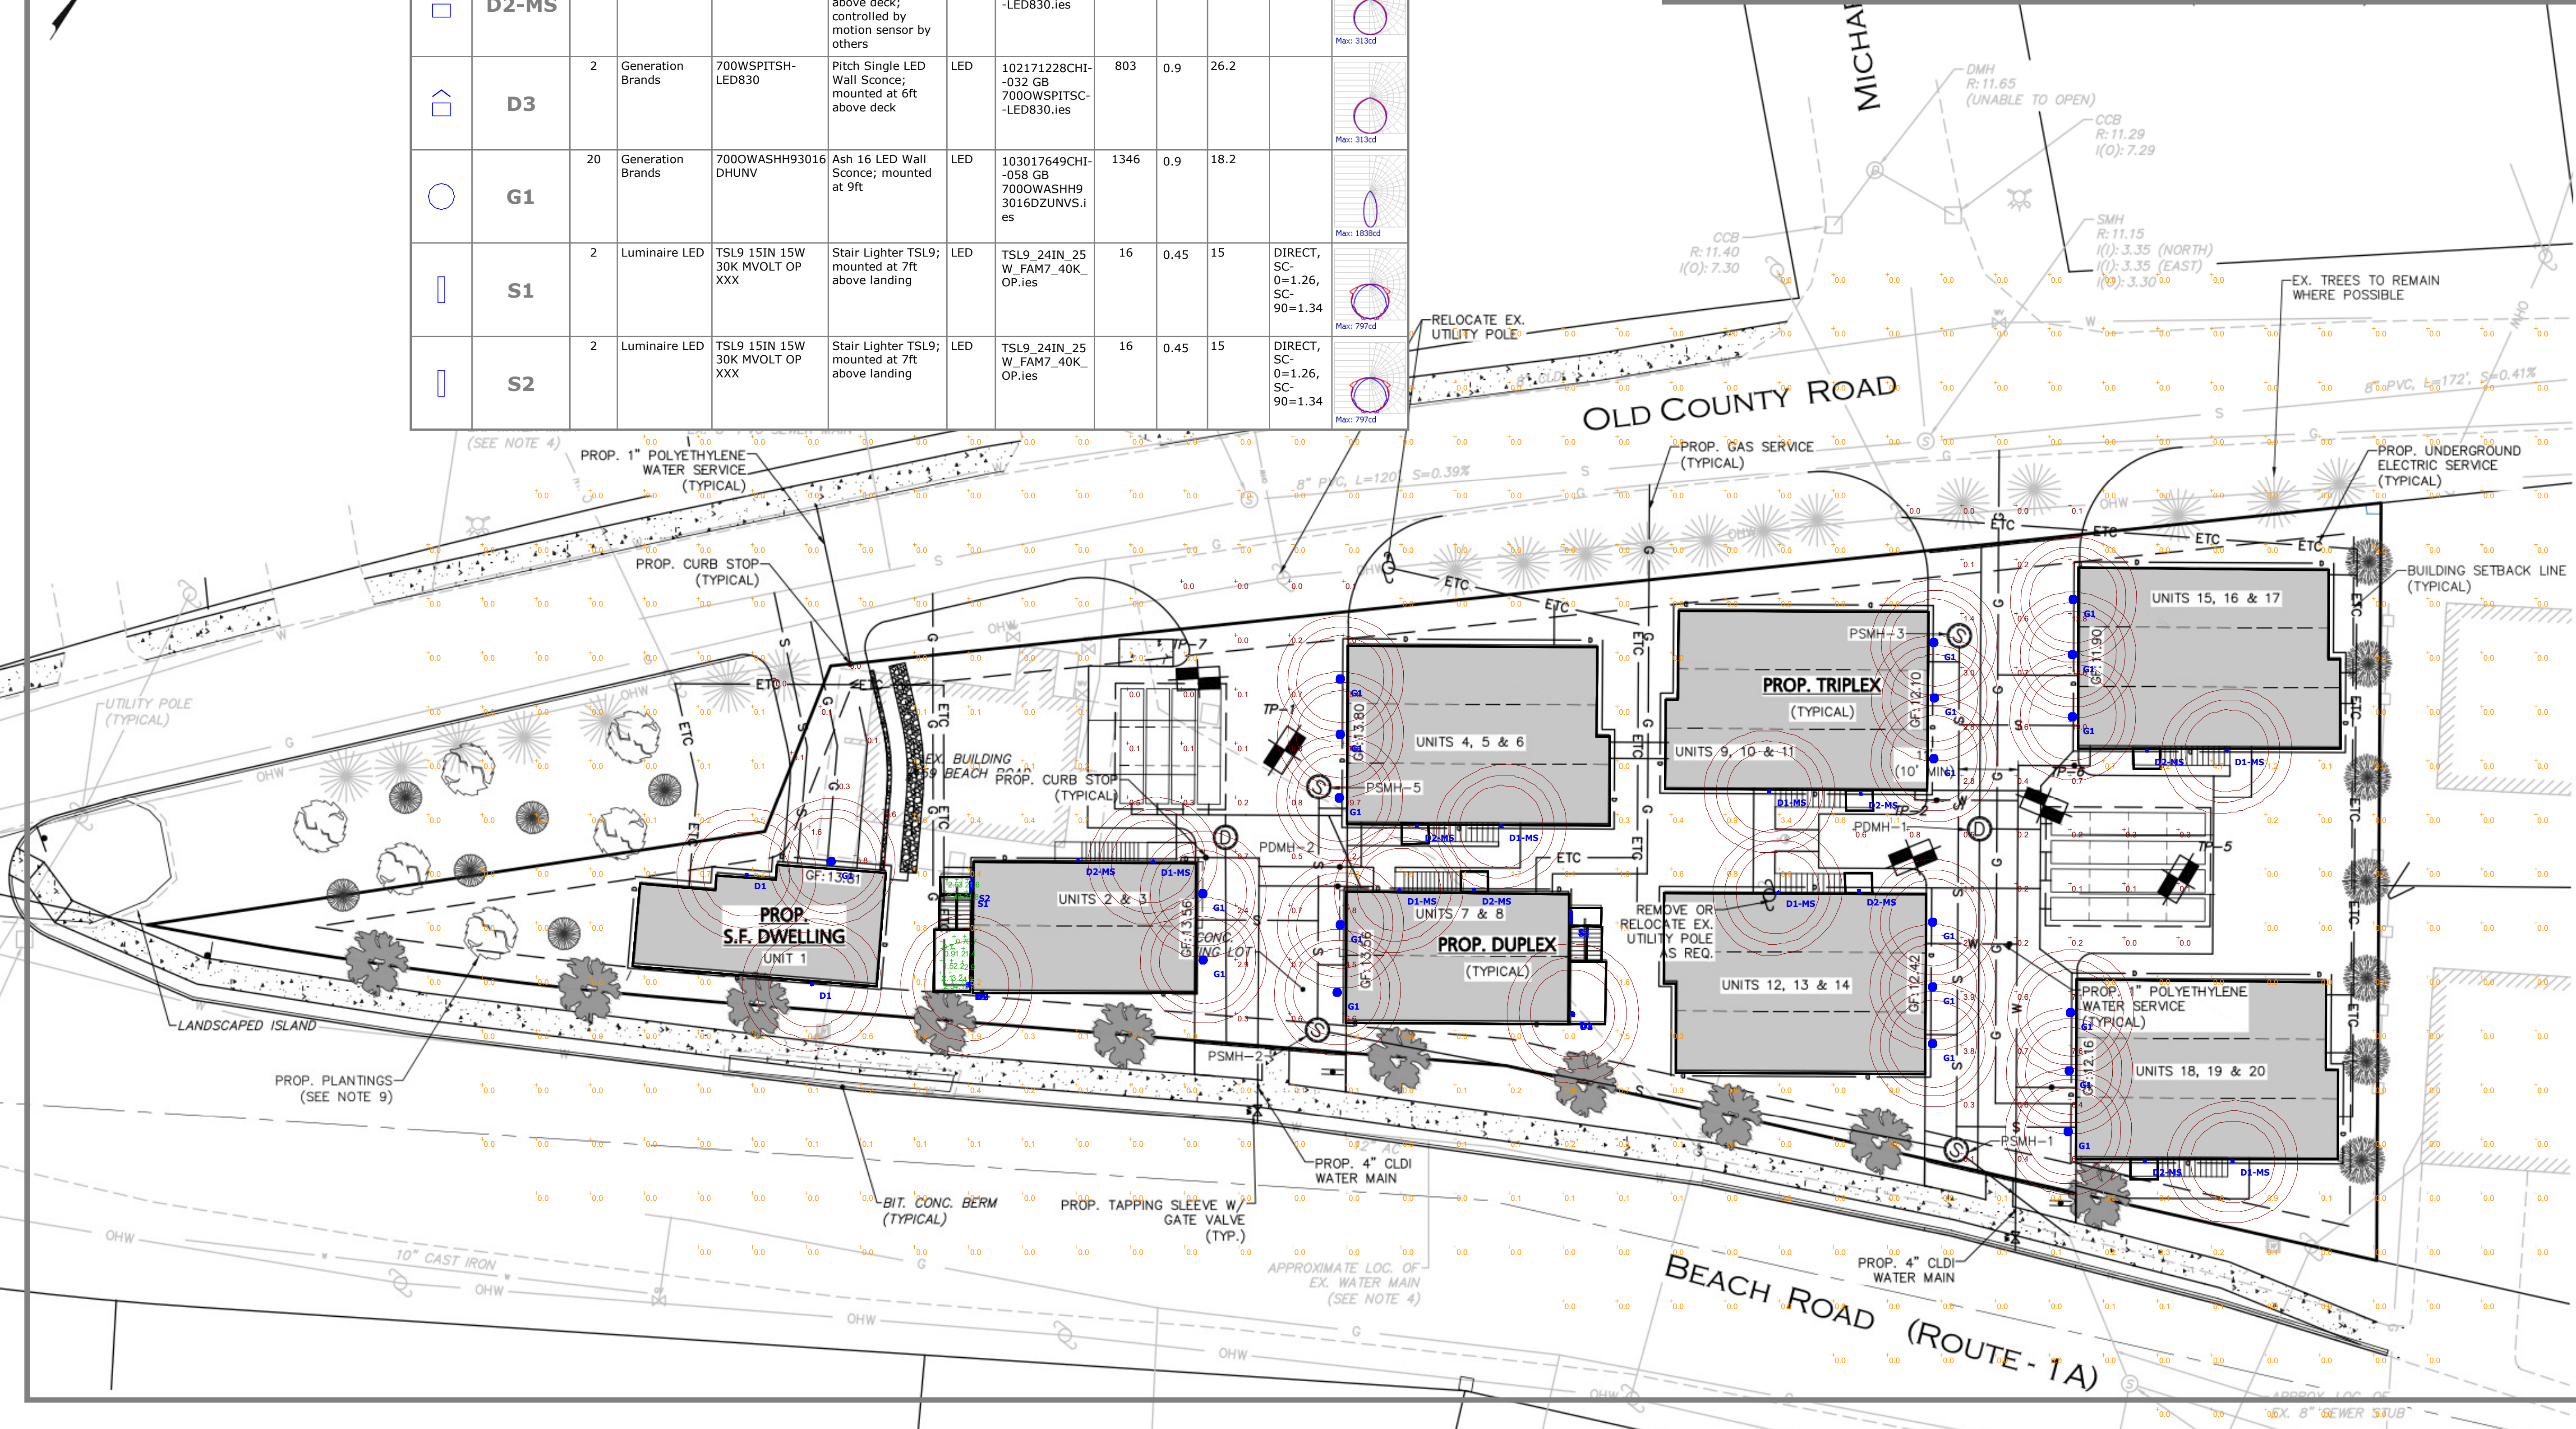

BEACH RD - SALISBURY
Site Lighting Layout

ENGINEER
APPROVED BY THE
PLANNING

CERTIFICATE OF
DATE OF ENDOR

5/2/23	REDESIGN
3/9/23	REDESIGN
1/3/23	REDESIGN
8/30/22	REV. PER
DATE	DESIGN
REVISIONS	

PREPARED FOR:
LARKIN F
GRO
383 M
MEDFIELD

PROJECT:
159 BEA
TAX MA
SALISBUR

DATE ISSUED: AUGU

PROJECT #: 21-102

PREPARED BY: WILLIA

Designer
Heidi G. Connors
Visible Light, Inc.
24 Stickney Terrace
Suite 6
Hampton, NH 03842
Date
5/17/2023
Scale
1"=16'
Drawing No.
Summary