


Schedule												
Symbol	Label	QTY	Manufacturer	Catalog Number	Description	Lamp	Filename	Lumens per Lamp	LLF	Wattage	Distribut ion	Polar Plot
	S4	1	Lithonia Lighting	DSX0 LED P1 30K TFTM MVOLT SPA DDBXD with SSS 12 4C DM19AS DDBXD	DSX0 LED Area Fixture; mounted at 14ft (12ft pole on 2ft base)	LED	DSX0_LED_P1_30K_TFTM_M VOLT.ies	4373	0.9	38	TYPE IV, SHORT, BUG RATING: B1 - U0 - G1	 Max: 3031cd
	S5	1	Lithonia Lighting	DSX0 LED P1 30K T5M MVOLT SPA DDBXD with SSS 12 4C DM19AS DDBXD	DSX0 LED Area Fixture; mounted at 14ft (12ft pole on 2ft base)	LED	DSX0_LED_P1_30K_T5M_MV OLT.ies	4540	0.9	38	TYPE VS, BUG RATING: B3 - U0 - G1	 Max: 1806cd
	W	9	Lithonia Lighting	WDGE1 LED P1 30K 80CRI VF SRM DDBXD	WDGE1 LED; mounted at 10ft	LED	WDGE1_LED_P 1_30K_80CRI_ VF.ies	1161	0.9	10.0002	TYPE II, VERY SHORT, BUG RATING: B0 - U0 - G0	 Max: 808cd



Statistics

Description	Symbol	Avg	Max	Min	Max/Min	Avg/Min
Outside of Parking Lot	+	0.3 fc	6.4 fc	0.0 fc	N/A	N/A
Parking Lot	+	0.8 fc	2.2 fc	0.2 fc	11.0:1	4.0:1

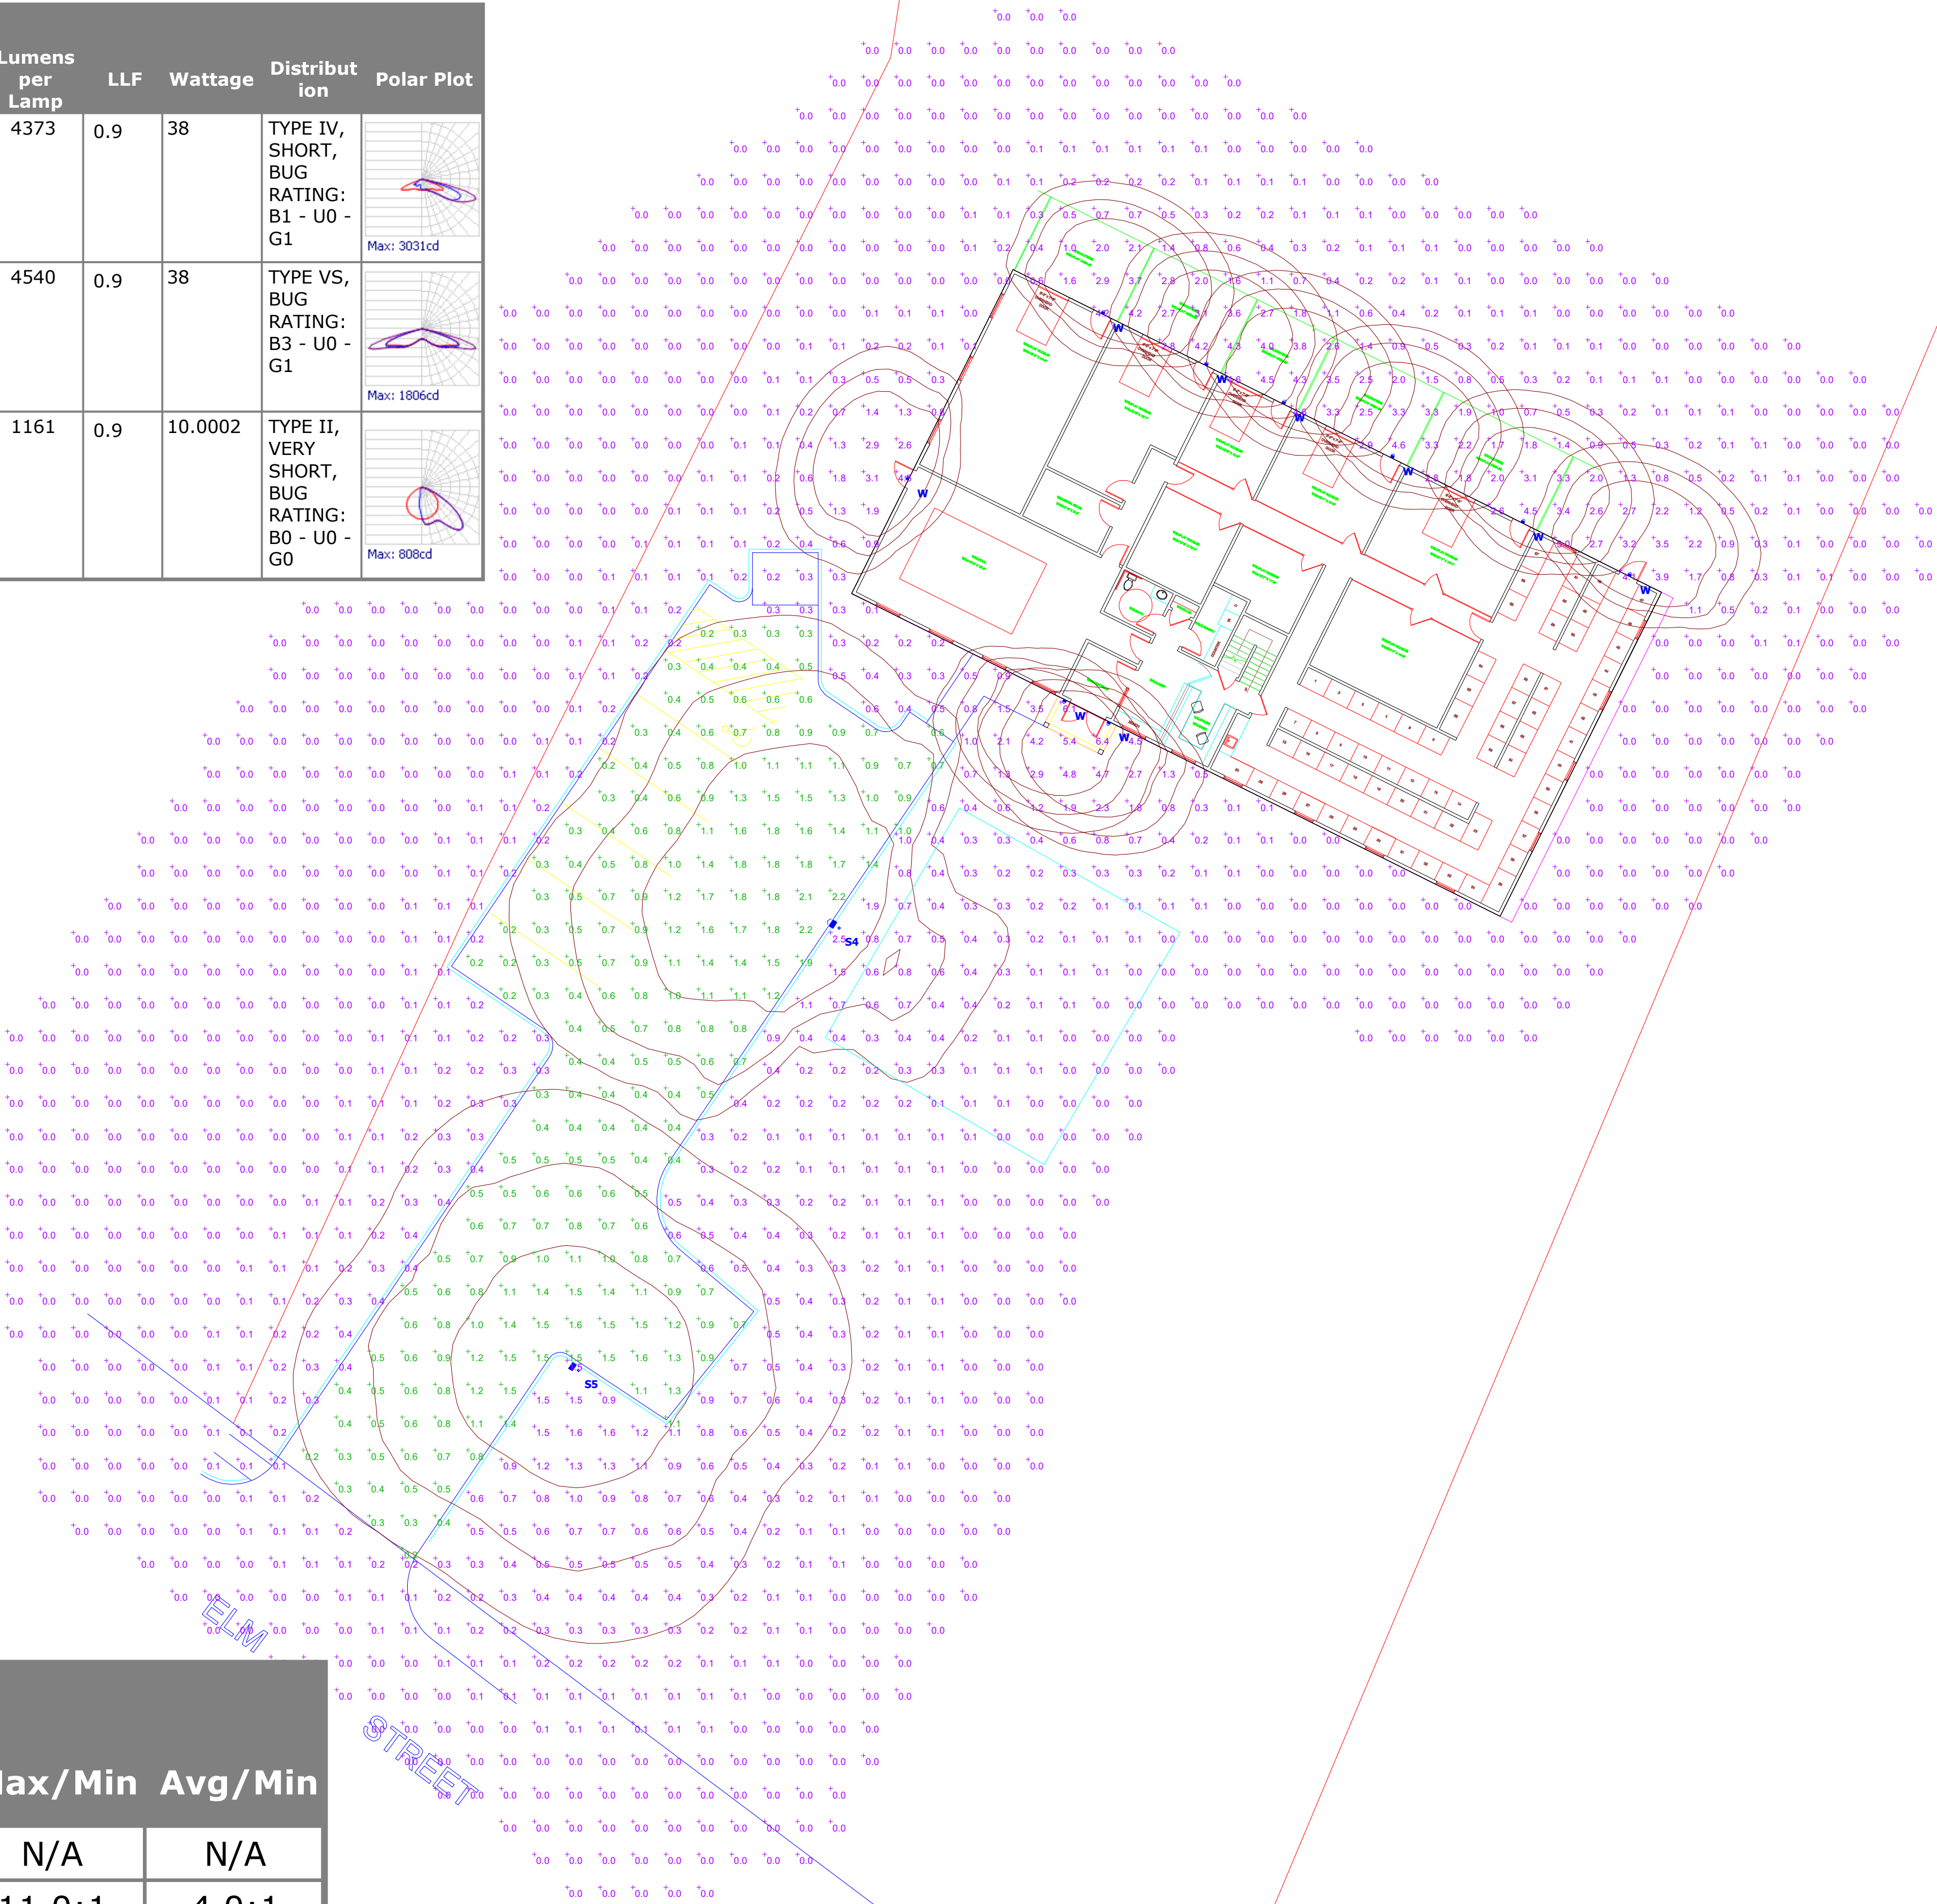

66 ELM ST - SALISBURY Site Lighting Layout

Designer
Heidi G. Connors
Visible Light, Inc.
24 Stickney Terrace
Suite 6
Hampton, NH 03842
Date
08/29/2022
Scale
1"=16'
Drawing No.
Summary